



594.75" OUTER HOLD DOWN BRACKET
(MODEL 5012FS SHOWN)

592.75" CL TO CL ANCHOR BOLT
(MODEL 5012FS SHOWN)

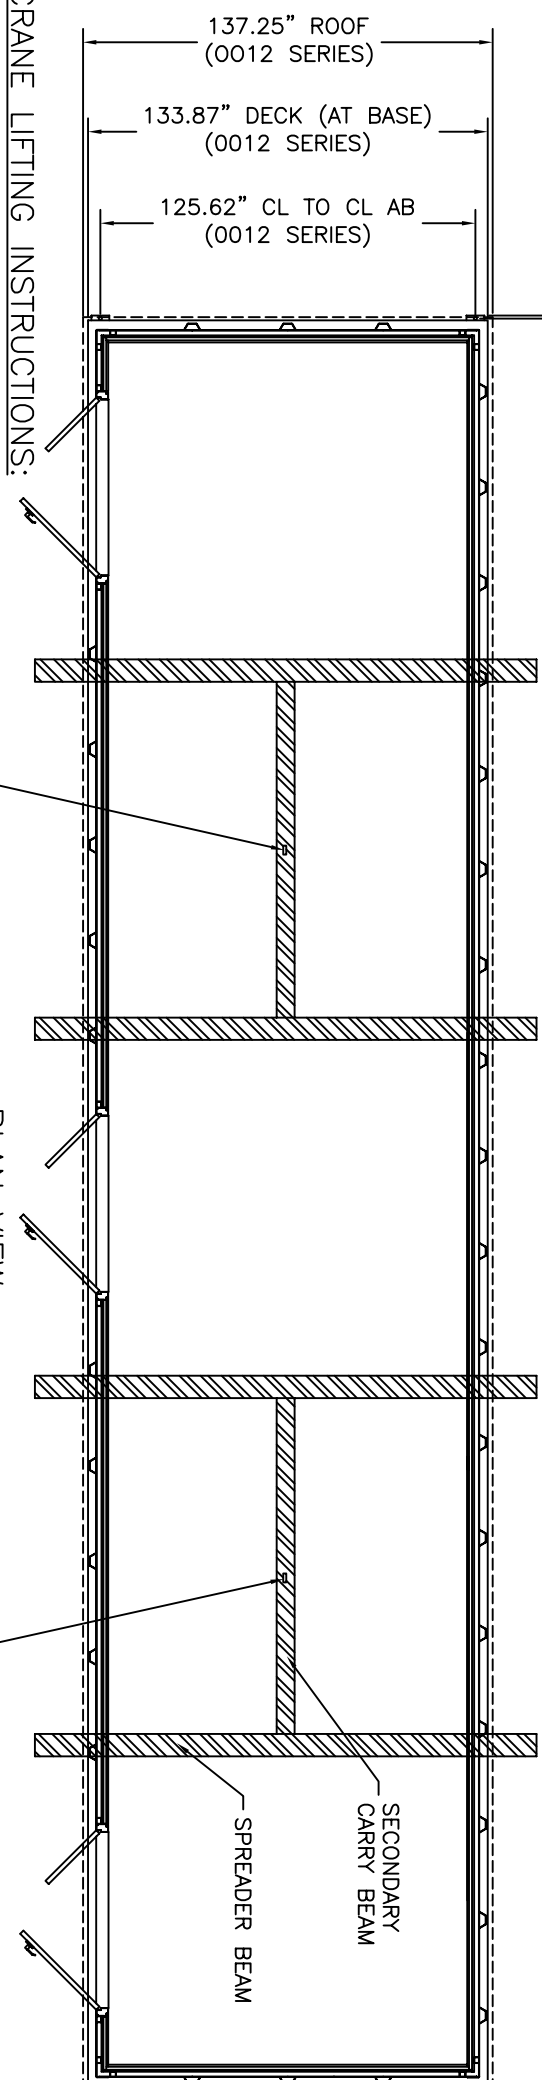

CRANE LIFTING INSTRUCTIONS:

1. LIFT WITH CAPACITY APPROVED CABLE OR STRAPS.
2. USE SPREADER BARS A MIN. OF 2 FEET WIDER THAN BUILDING ROOF TO PREVENT DAMAGE TO FRONT AND REAR ROOF OVERHANGS.
3. KEEP ONE END OF THE BUILDING TETHERED AT ALL TIMES TO PREVENT BUILDING FROM SWINGING IN AN UNCONTROLABLE MANNER.

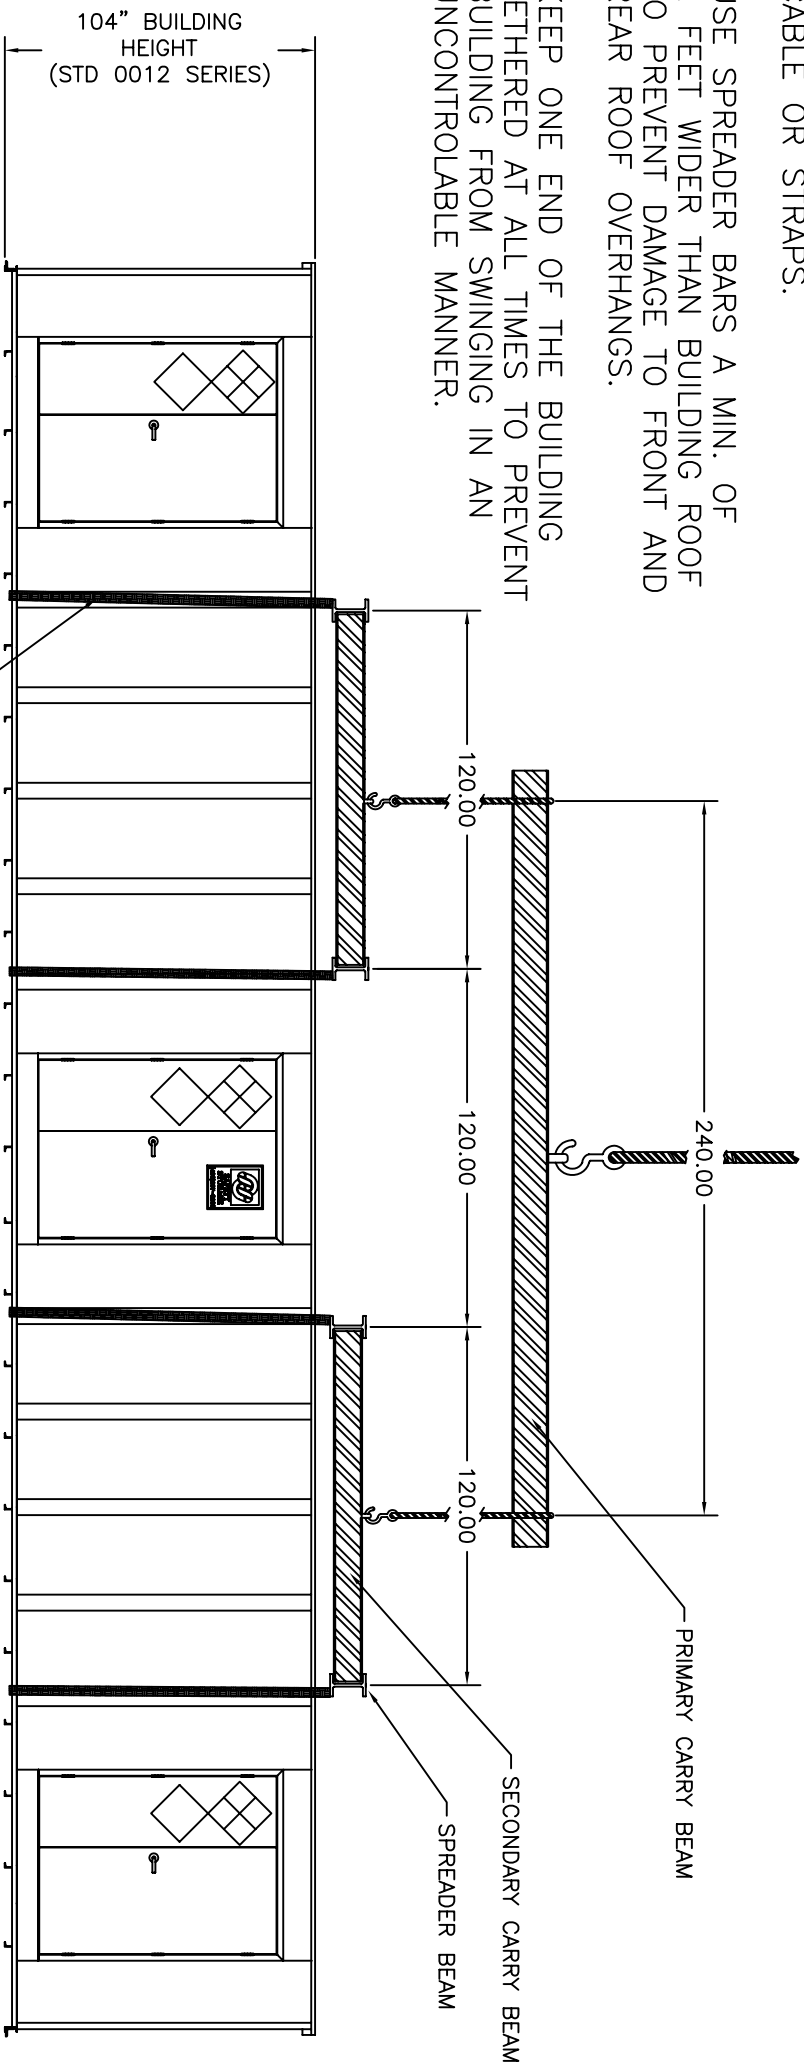

FRONT VIEW


LIFTING STRAP (TYPICAL)

| REVISIONS | | | |
|-----------|-----------------|---------|----------|
| REV | DESCRIPTION | DATE | APPROVED |
| A | INITIAL RELEASE | 1/12/98 | JJD |

PLEASE NOTE:
THE 4 STRAP LIFTING CONFIGURATION IS SHOWN FOR A MODEL 5012FS. THE MODEL 5012FS IS THE LARGEST BUILDING IN THE "0012FS" BUILDING SERIES AND SHOWN FOR REFERENCE ONLY.

LOCATE LIFT STRAPS FOR PROJECT SPECIFIC BUILDING FOR A BALANCED LIFT.

ELECTROCUTION HAZARD CHECK
OVERHEAD CLEARANCE BEFORE MOVING BUILDING. AREA MUST BE FREE OF OVER HEAD ELECTRICAL, PLUMBING OR OTHER POTENTIALLY DANGEROUS OBJECTS.

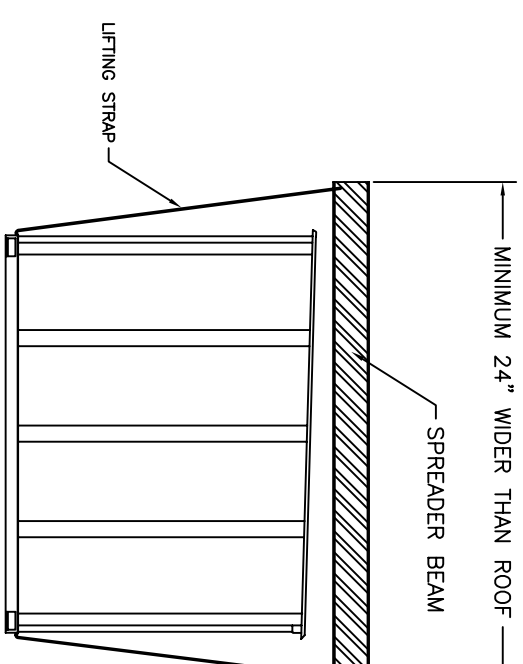

RIGHT SIDE VIEW

COPYRIGHT © 1996 BY SAFETY STORAGE, INC.
ALL RIGHTS RESERVED
THESE DOCUMENTS ARE NOT TO BE REPRODUCED FOR ANY PURPOSE, IN WHOLE OR IN PART, WITHOUT WRITTEN PERMISSION FROM SAFETY STORAGE, INC.

| | | | | |
|---------------------------------------------------------------------|------------------|------------|---------------------------------------------------------------------------------------------|--------------|
| APPROVALS | | DATE | 2301 BERT DRIVE HOLLISTER, CA 95023 PHONE: (408)837-5955 FAX: (408)837-7403 | |
| UNLESS OTHERWISE SPECIFIED: ALL DIMENSIONS ARE IN INCHES ± 1" | DRAWN BY: JJD | 1/12/98 | <p>SAFETY STORAGE FOUR (4) STRAP LIFT CONFIGURATION (MODEL 5012FS SHOWN)</p> | |
| INTERVALS: | CHECKED BY: | | | |
| | MFG: SSI | | | |
| REV. NUMBER: | NEXT ASSY: | | SIZE: DRAWING NO. OFFLOAD5012FS | REV. A |
| DO NOT SCALE DRAWING | | SCALE 1/32 | FILE: OFFLOAD5012FS | SHEET 1 OF 1 |